


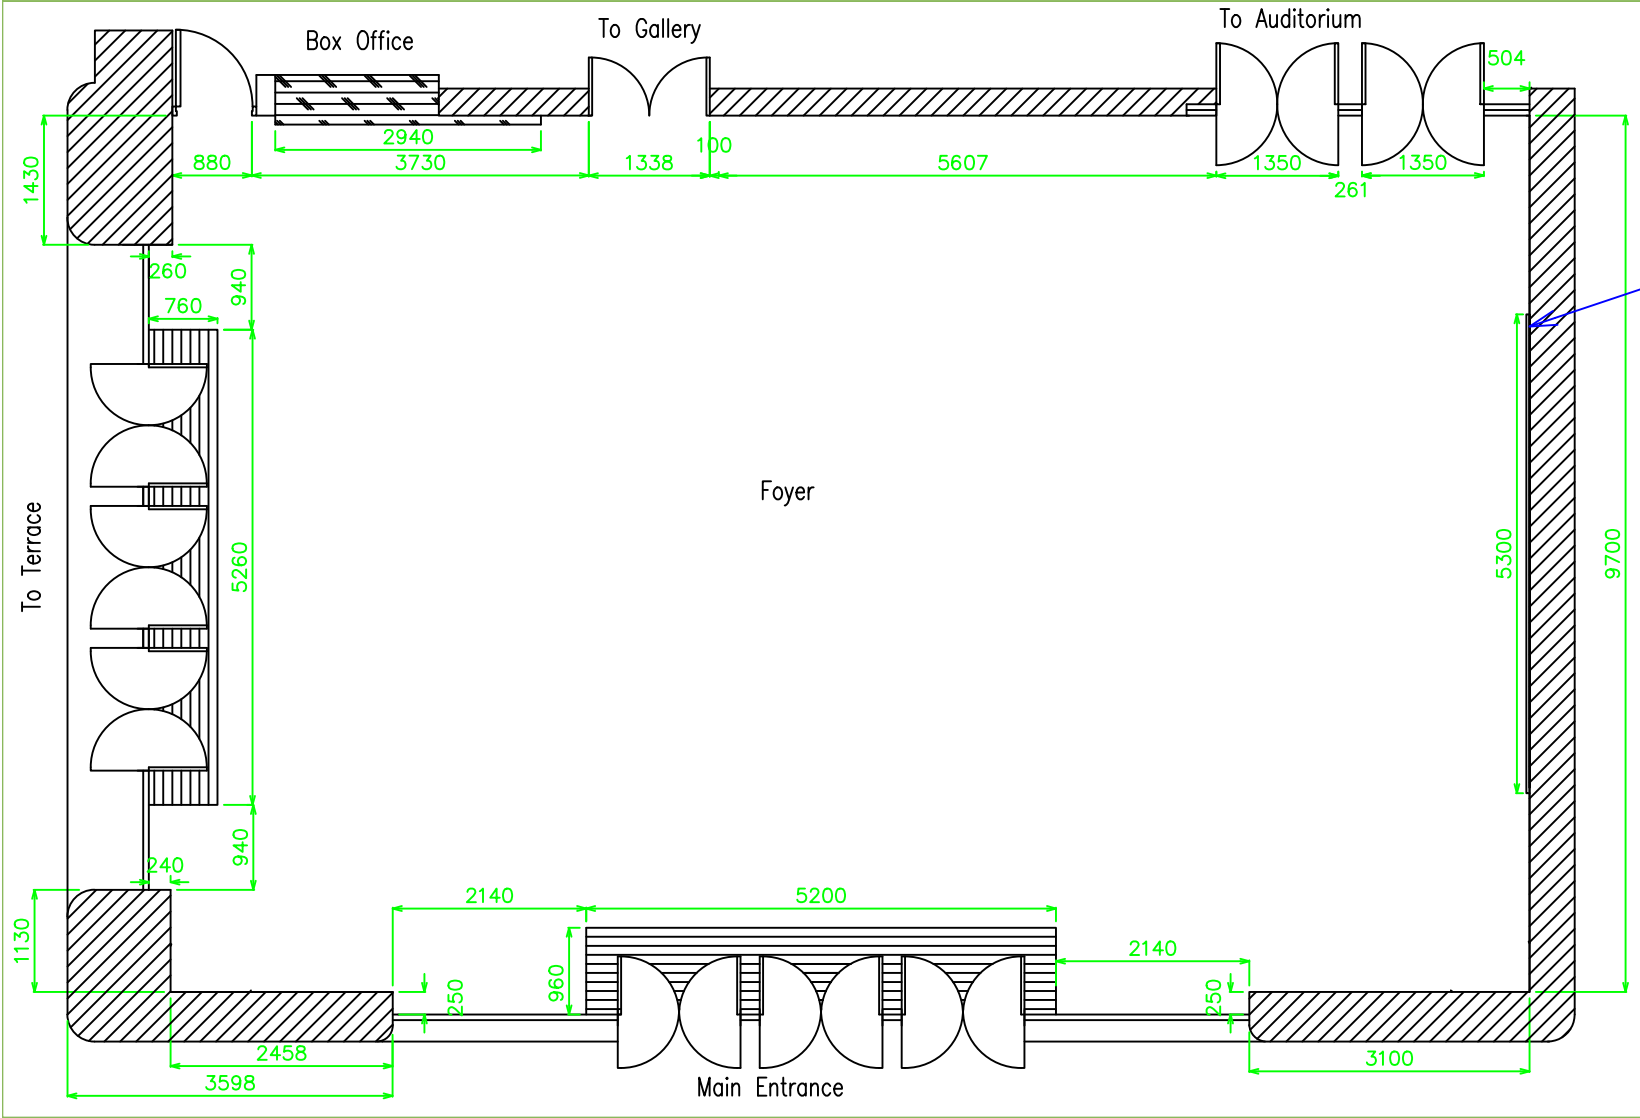

LED WALL Size:5300mm(L) x 3240mm(H) x 35mm(W)

Venue			
Sir Run Run Shaw Hall, CUHK			
Drawing Title			
Foyer Floor Plan			
dimension	unit	Scale	Drawing Number
mm	draw to scale	FFP1	1.2
Drawn by		Date	
Rex Chan		6 May 2025	